


2 REFLECTED CEILING PLAN
 A1 SCALE: 1/4"=1'-0"

- 1 NEW ENERGY EFFICIENCY ELEC. WATER HEATER ON METAL PEDESTAL (SEE OWNER FOR SIZE AND TYPE)
- 2 NEW 20x24 THERMOPLASTIC UTILITY SINK ON LEGS. CONNECT TO EXISTING FITTINGS
- 3 ELEC. DRYER 4-PRONG NEMA OUTLET
- 4 NEW WASHER
- 5 COUNTERTOP AND SINK (PROVIDED BY OWNER)
- 6 NEW 10LB. ABC FIRE EXTINGUISHER
- 7 STYLING CHAIR (BY OWNER)
- 8 SHAMPOO CHAIR (BY OWNER)
- 9 DISPLAY CASE (BY OWNER)
- 10 RECEPTION COUNTER (BY OWNER)

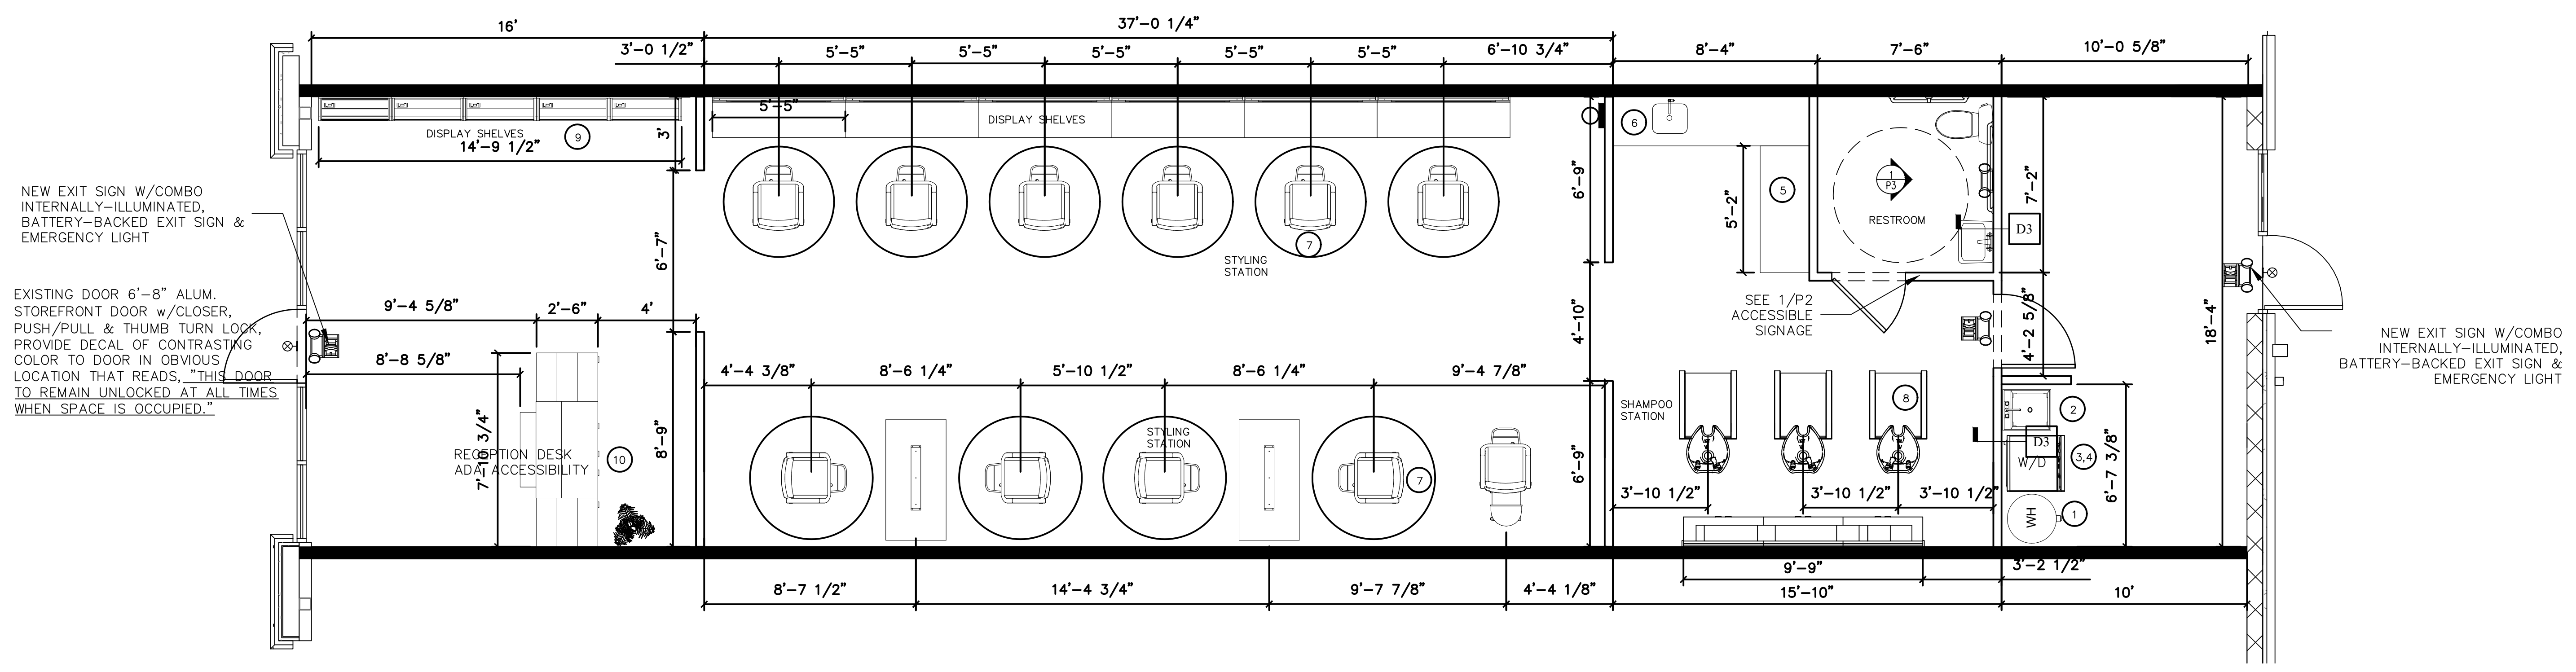

1 FLOOR PLAN
 A1 SCALE: 1/4"=1'-0"